




ATTENUATION TANK 1.
REFER TO DRAWING D111-CSC-XX-XX-DR-C-0002_Proposed Drainage Layout
SCALE 1:100

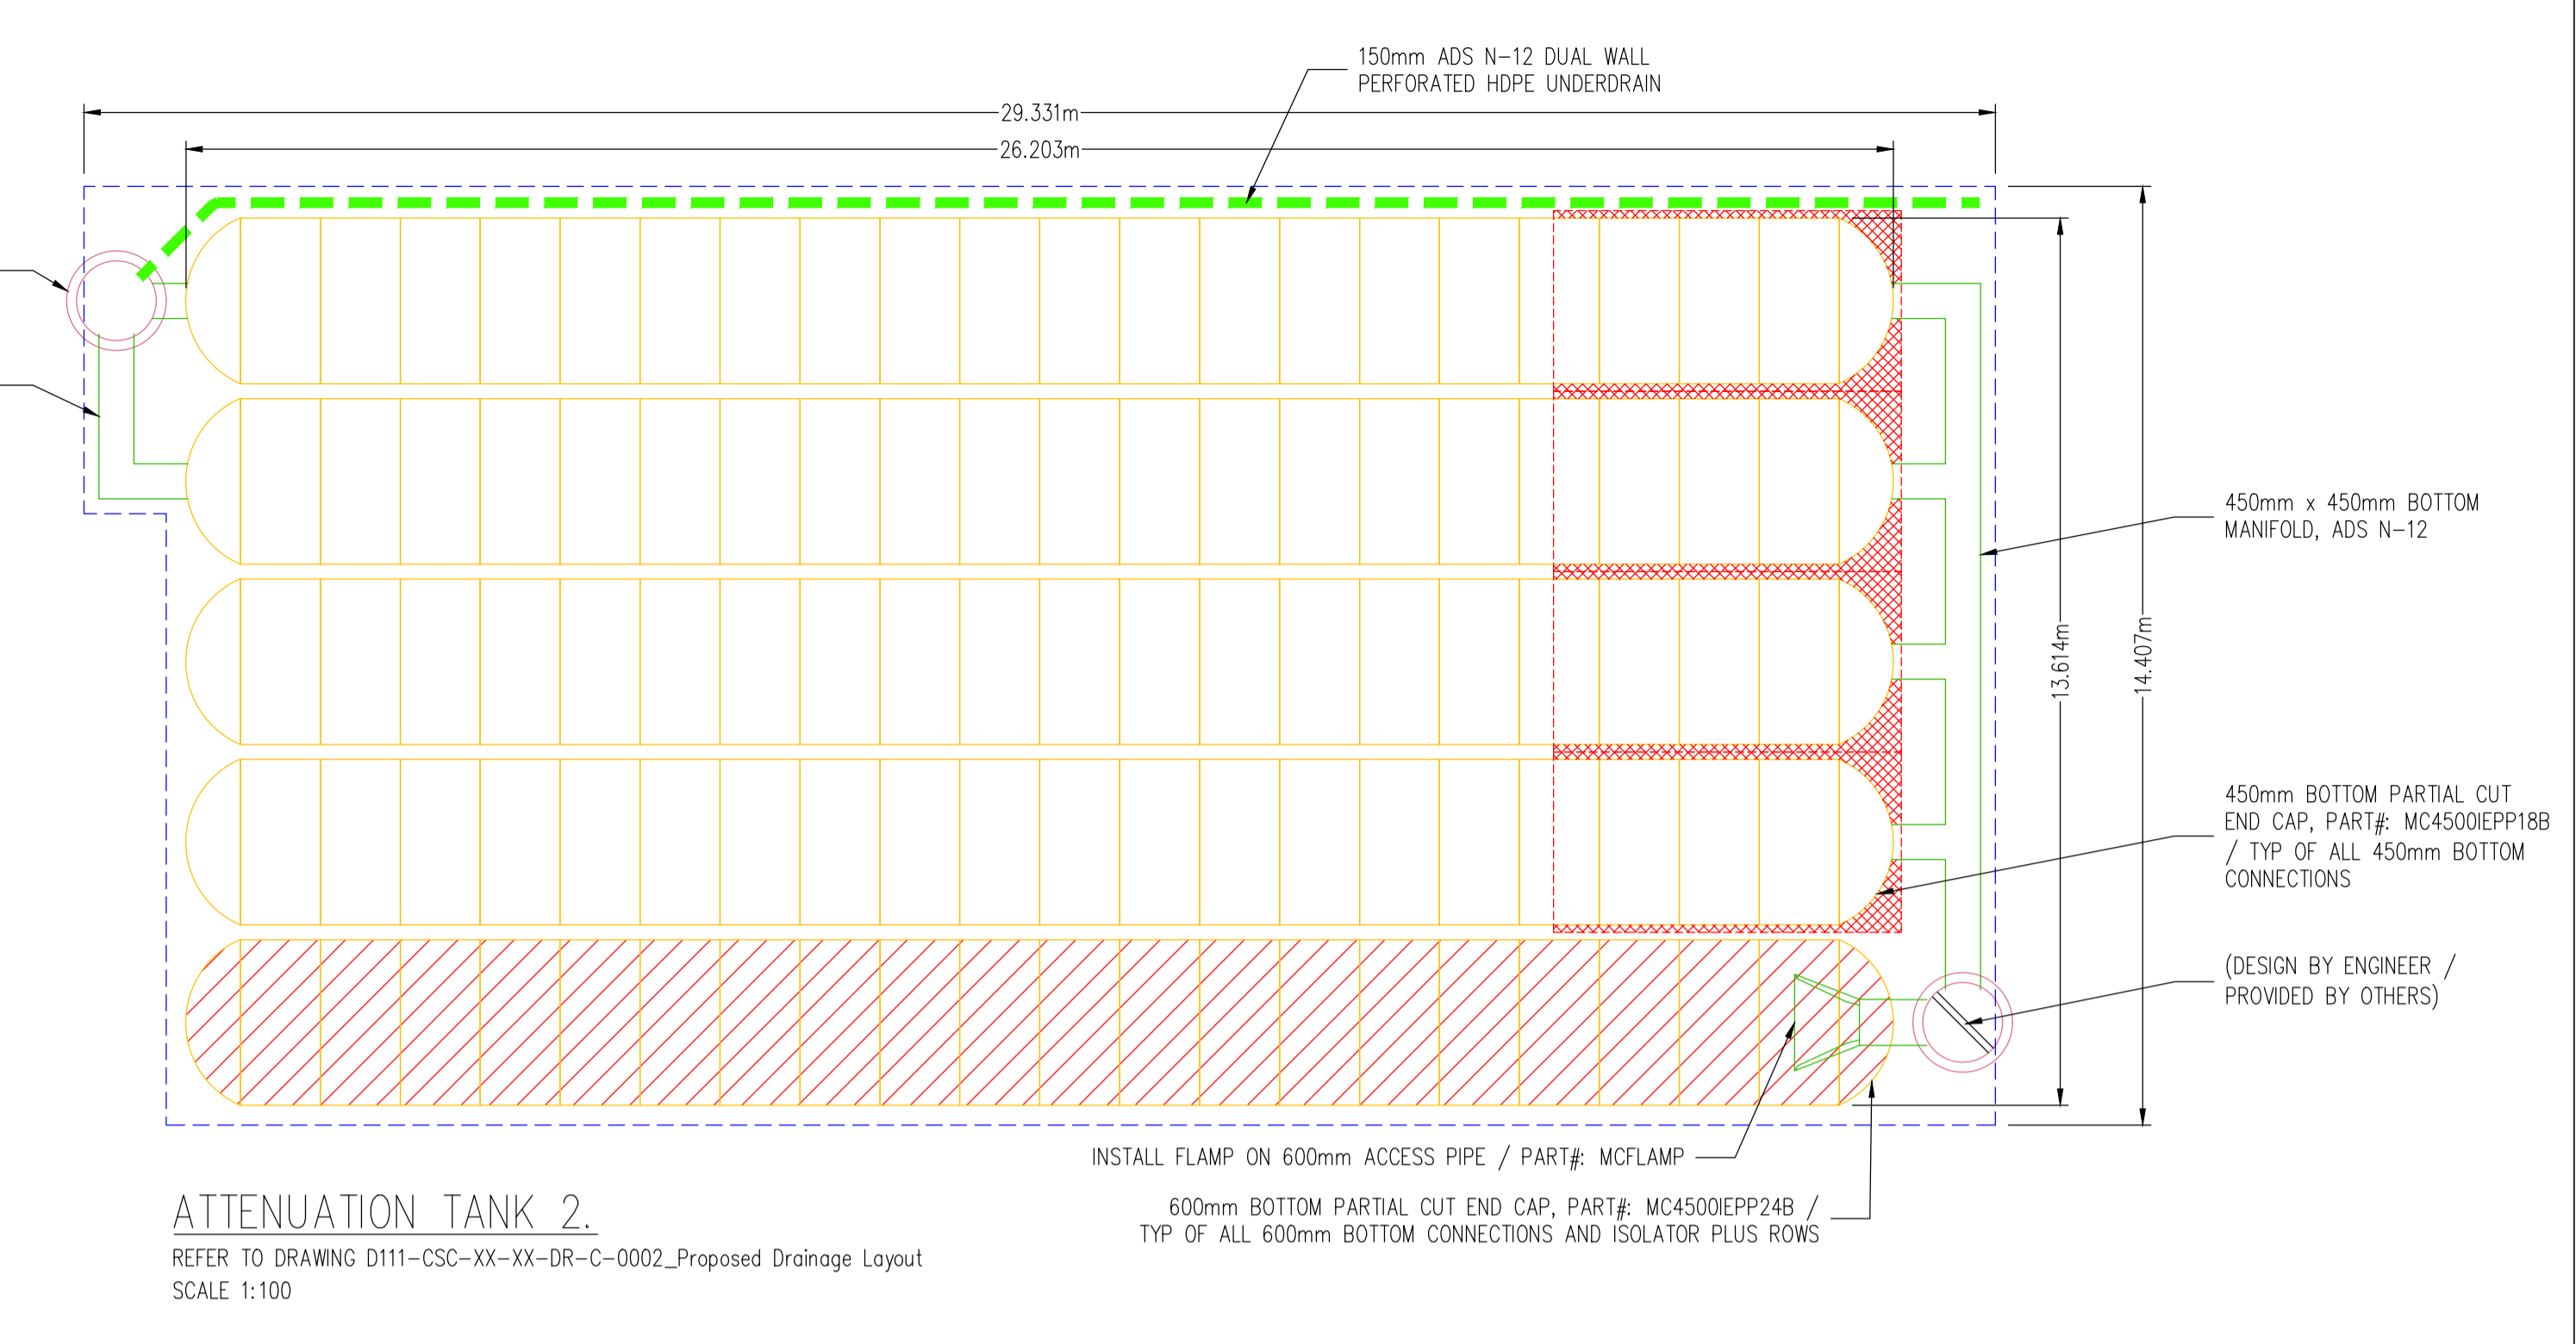

ATTENUATION TANK 2.
REFER TO DRAWING D111-CSC-XX-XX-DR-C-0002_Proposed Drainage Layout
SCALE 1:100

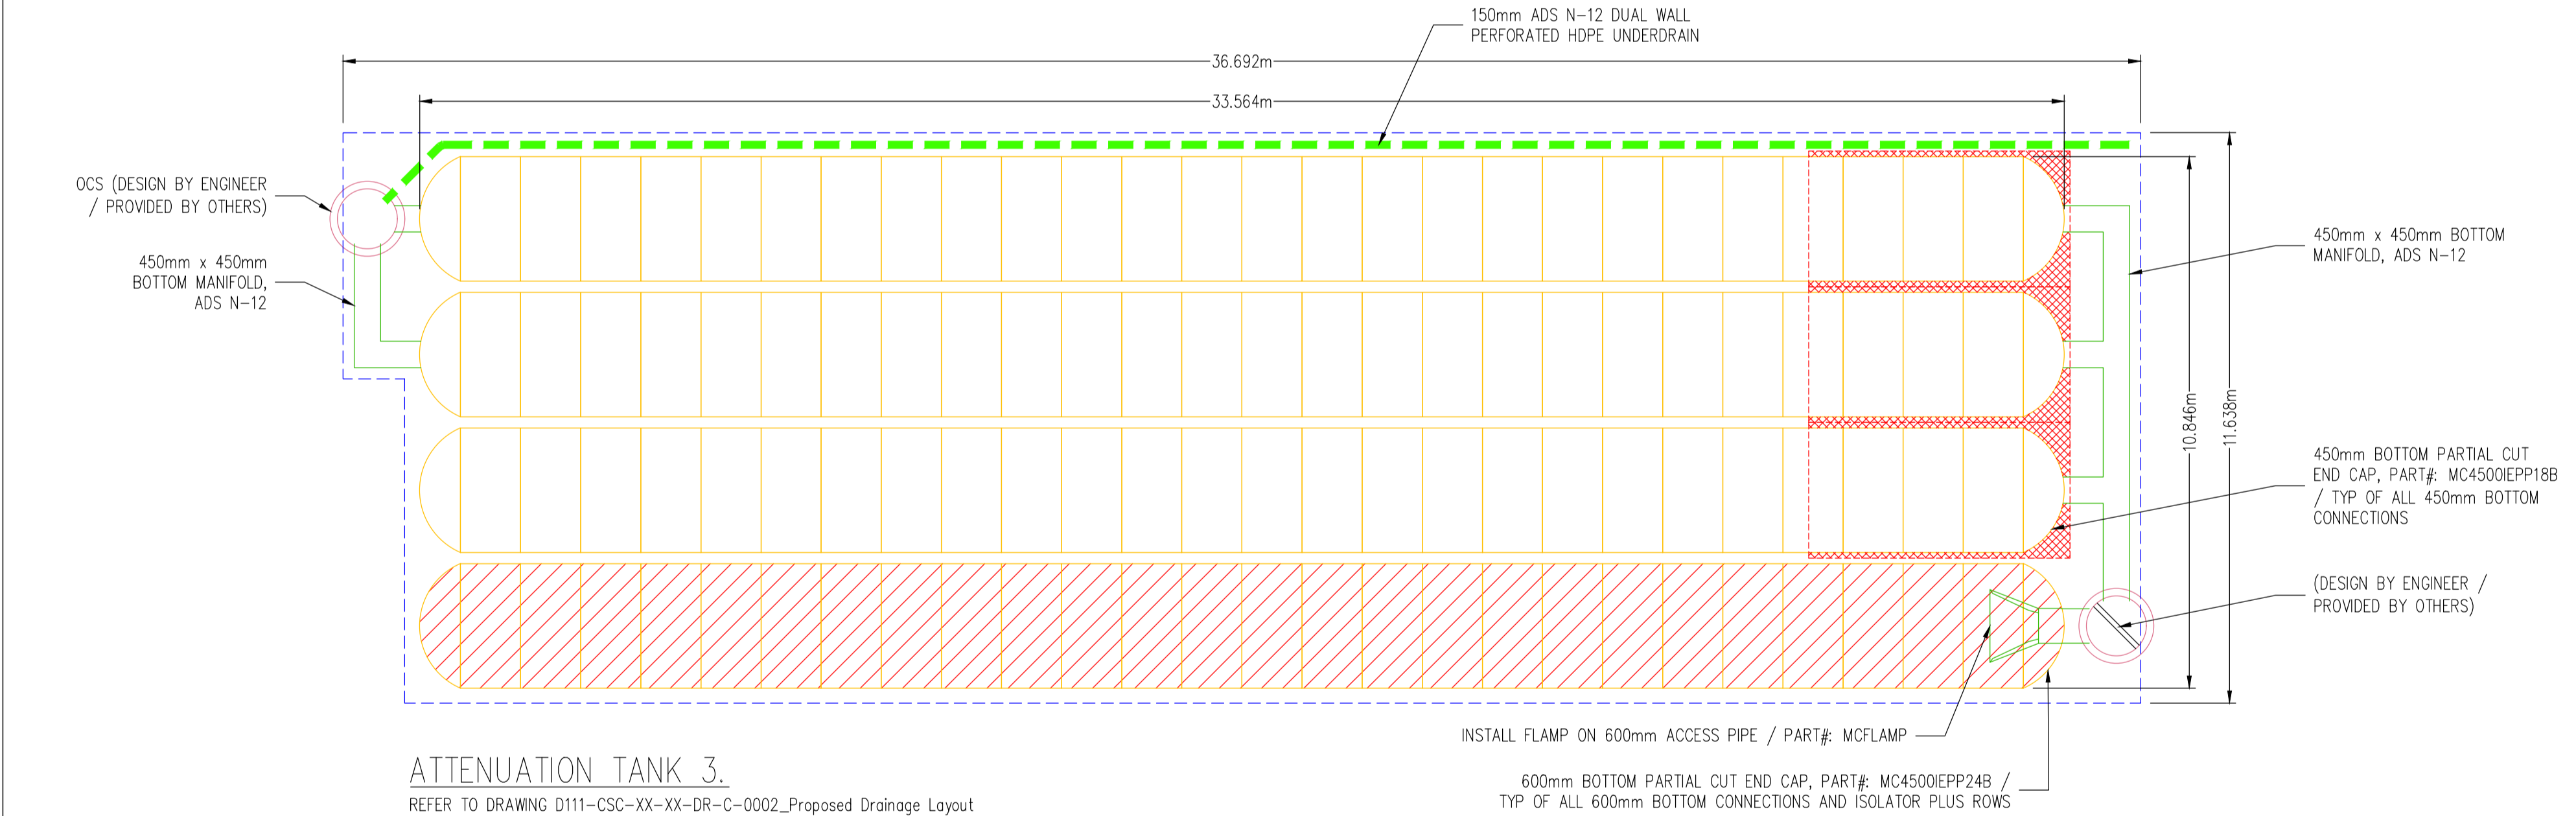

ATTENUATION TANK 3.
REFER TO DRAWING D111-CSC-XX-XX-DR-C-0002_Proposed Drainage Layout
SCALE 1:100

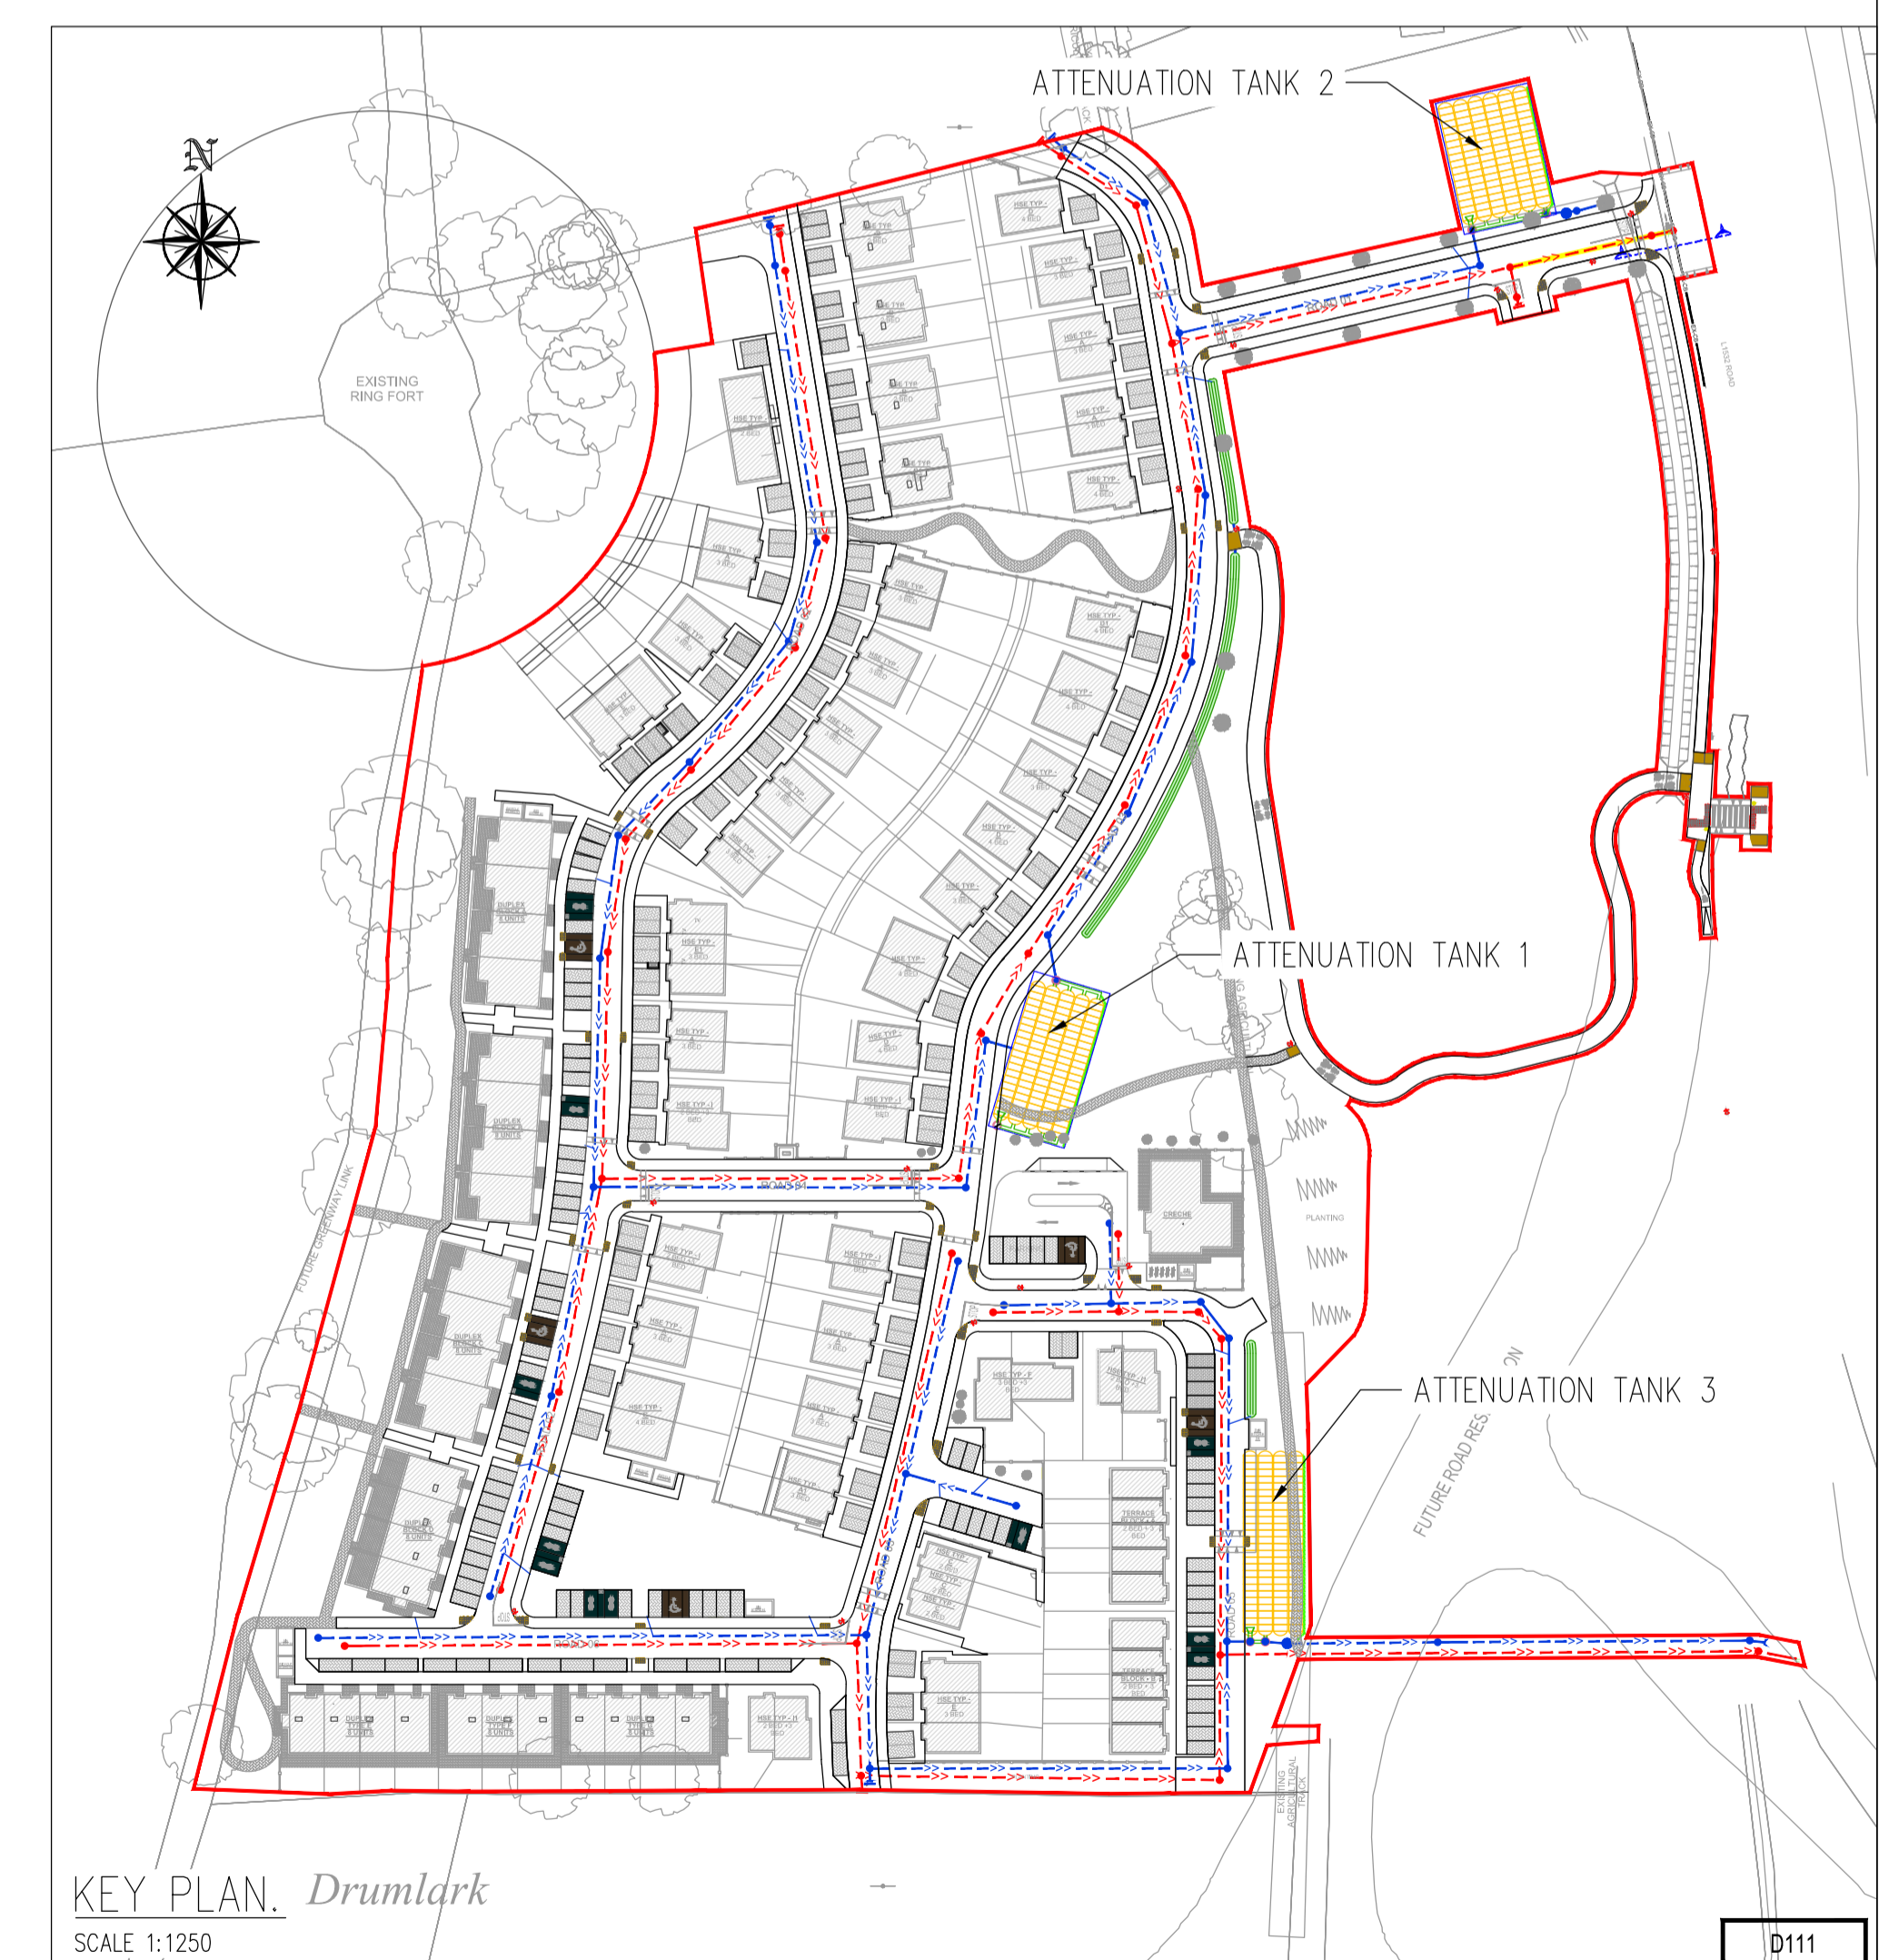

PLANNING DRAWING.
NOT FOR CONSTRUCTION.
ALL LEVELS GIVEN ARE
RELATIVE TO ORDNANCE DATUM.
THIS DRAWING HAS BEEN ISSUED FOR INFORMATION
PURPOSES ONLY AND MUST NOT BE USED
FOR CONSTRUCTION UNDER ANY CIRCUMSTANCES

- NOTES**
- For setting out refer to Architect's drawings.
 - This drawing to be read in conjunction with all other Architectural and Engineering drawings and all other relevant drawings and Specifications.
 - DO NOT SCALE THIS DRAWING. Use figured dimensions only.
 - No part of this document may be reproduced or transmitted in any form or stored in any retrieval system of any nature without the written permission as copyright holder except as agreed for use on the project for which the document was originally issued.
 - Ordnance Survey Ireland Licence Number EN 0074024

Rev. No.	Date	REVISION NOTE
P1	17.07.2023	ISSUED FOR STAGE 2
P2	22.02.2024	ISSUED FOR PLANNING

Drn. By	Chkd. By	Architect	Project	Title	Dwg. No.	Date	Drn. By	Chkd. By	Aprvd. By	Scale	Revision
SC	NB	Michael Fitzpatrick (MFA)	Drumlark Development Co. Cavan	Proposed Attenuation Tank Details	D111-CSC-XX-XX-DR-C-0023	June 2023	SC	JF	NB	As Shown @ A1	P2

Architect		Project		Title		Dwg. No.		Date		Drn. By		Chkd. By		Aprvd. By		Scale		Revision	
Michael Fitzpatrick (MFA)		Drumlark Development Co. Cavan		Proposed Attenuation Tank Details		D111-CSC-XX-XX-DR-C-0023		June 2023		SC		JF		NB		As Shown @ A1		P2	

CS Consulting Group
DUBLIN | LONDON | LIMERICK

Head Office
19-22 Dame Street, Dublin 2.
T: +353 (0)1 5480863
E: info@csconsulting.ie
W: www.csconsulting.ie

Quality Environment I.S. EN ISO 9001:2008
Energy I.S. EN ISO 14001:2004
Health & Safety I.S. EN ISO 50001:2011
OHSAS 18001:2007