
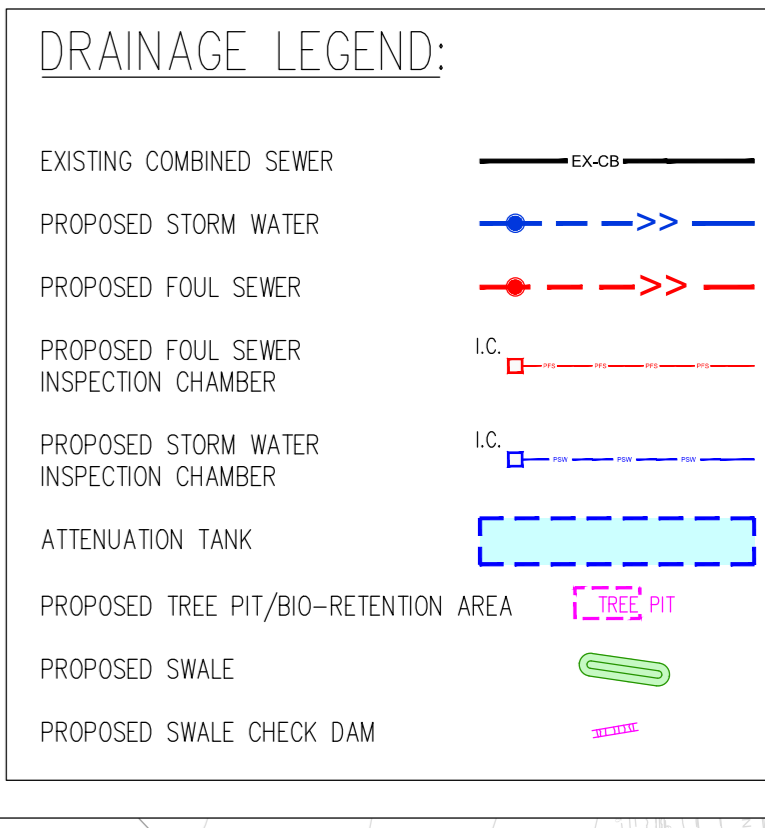
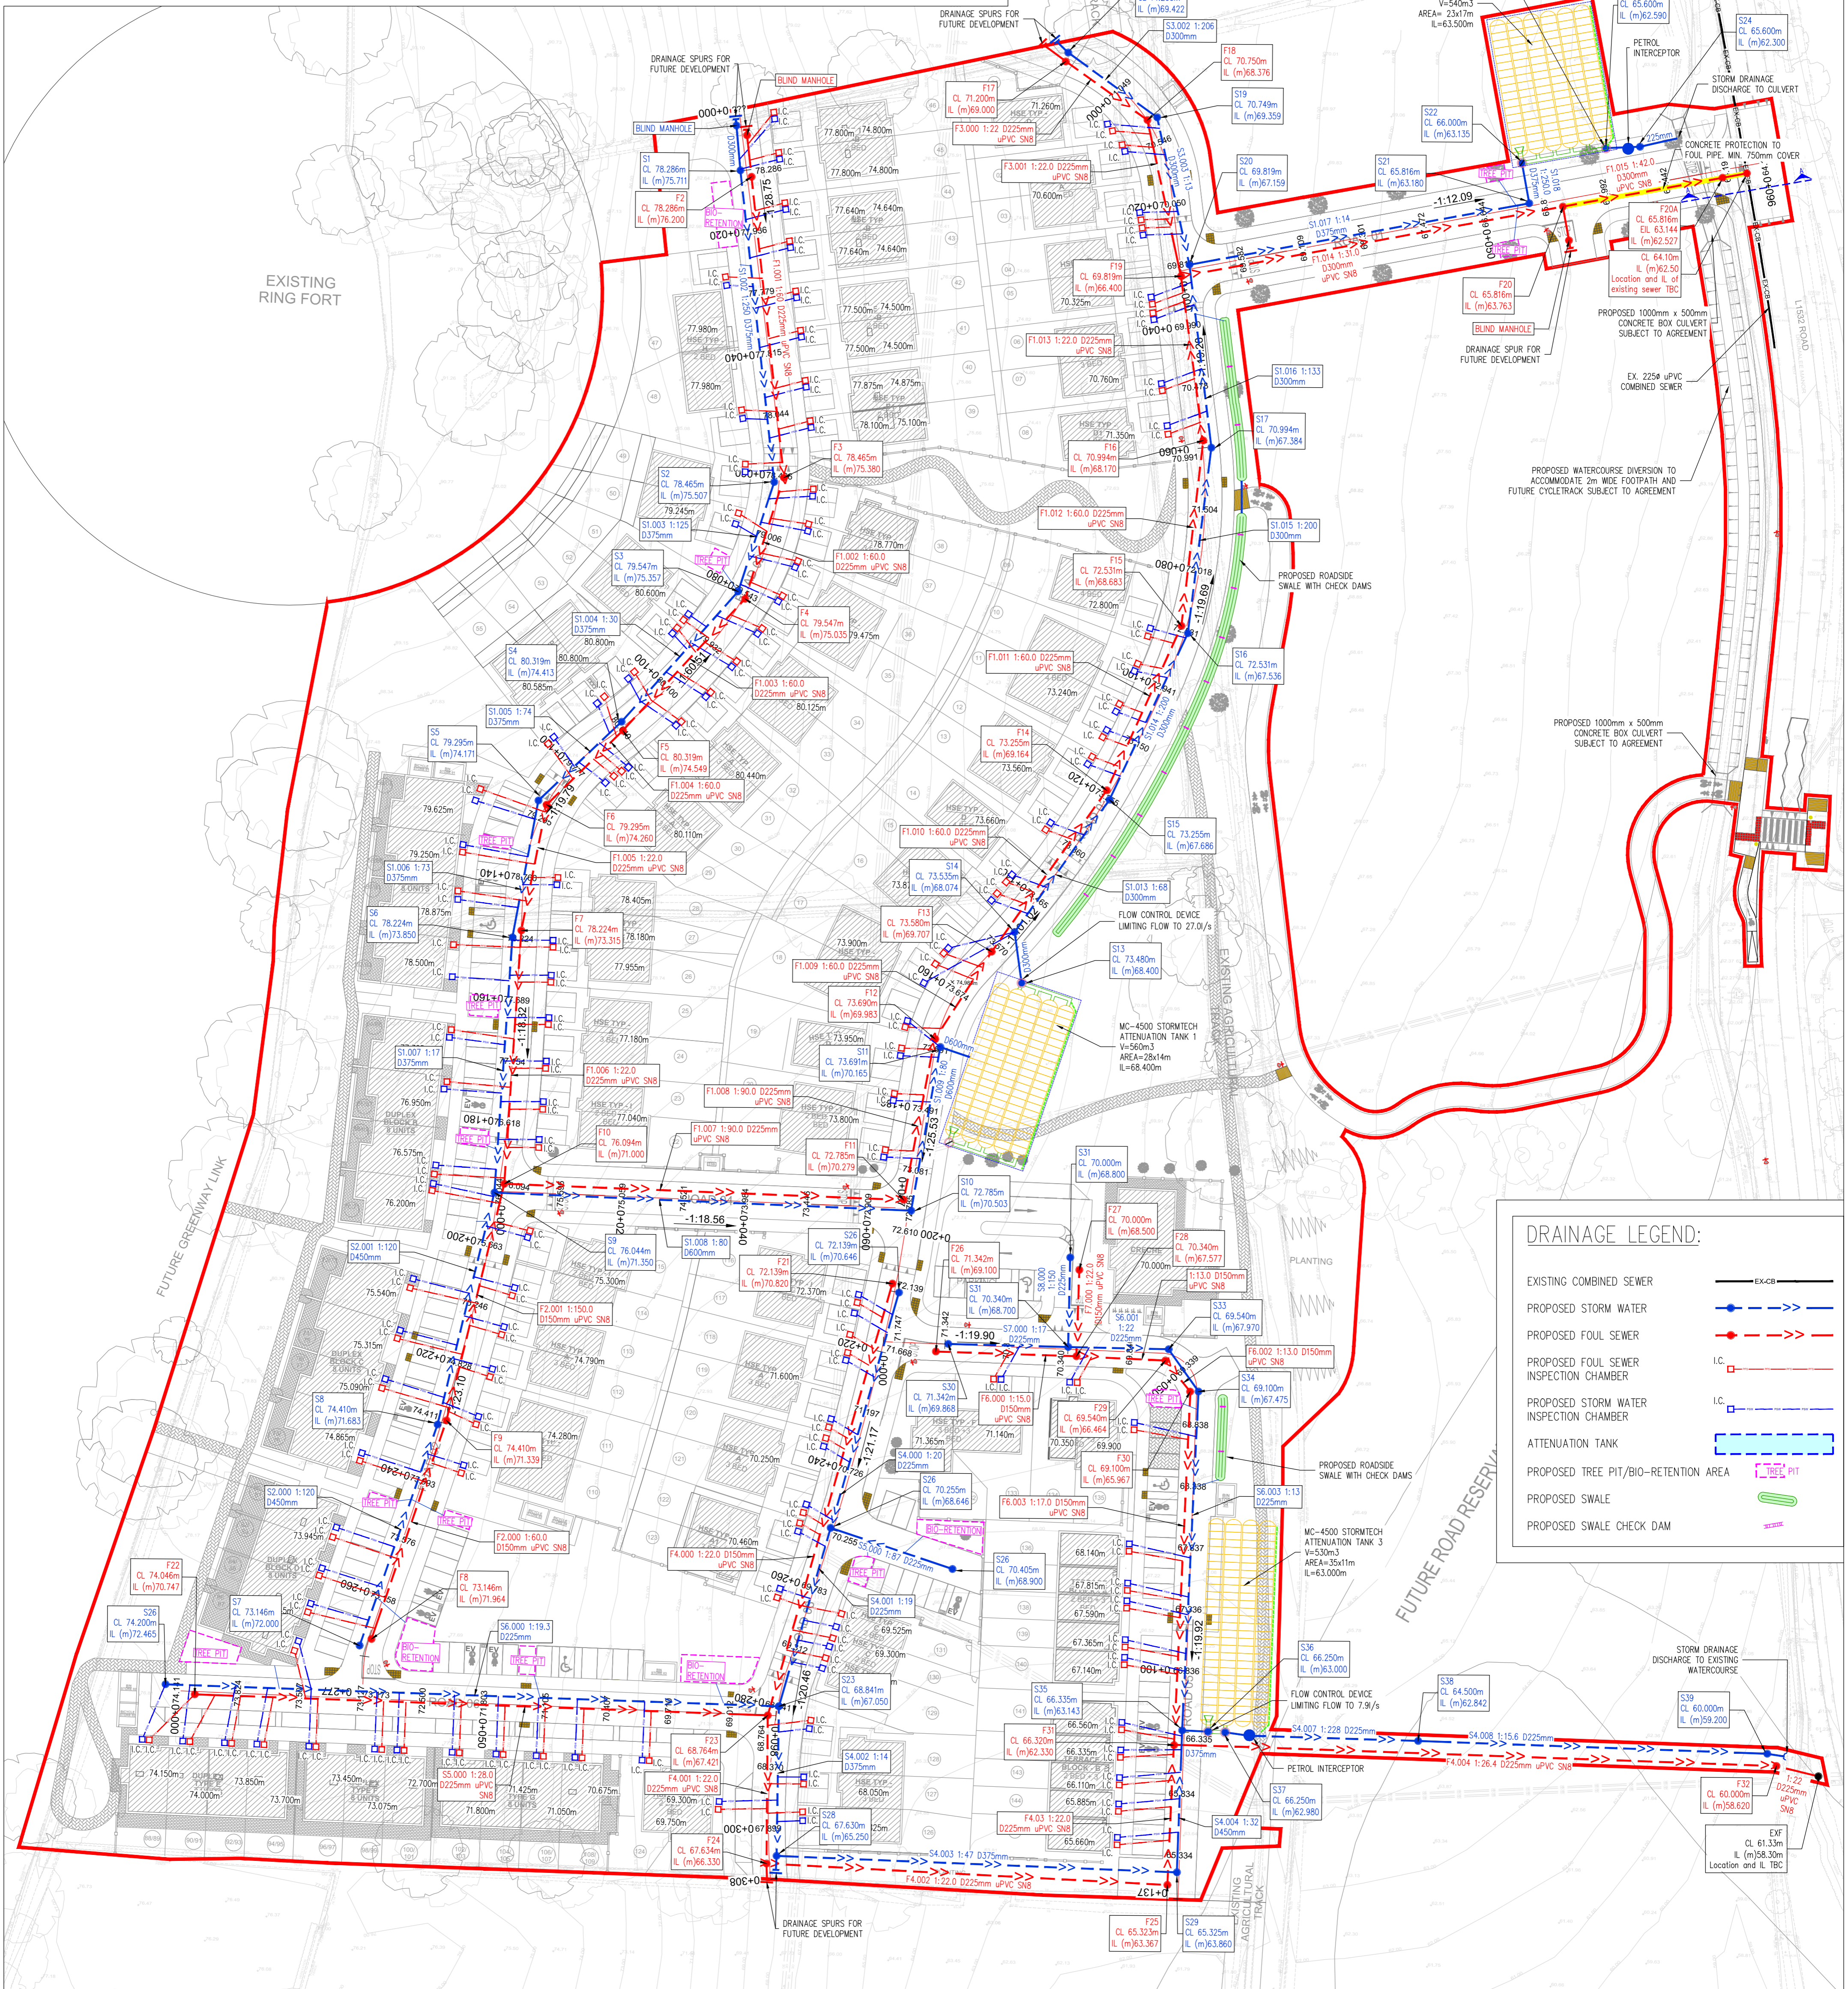


SECTION A-A
SCALE: 1:50

DRAWINGS REFERENCES:

- REFER TO DRAWING D111-CSC-XX-DR-C-0004 TO 0006 FOR PROPOSED DRAINAGE DETAILS.
- REFER TO DRAWINGS D111-CSC-XX-DR-C-0019 & 0020 FOR SUDS LAYOUT AND DETAILS.

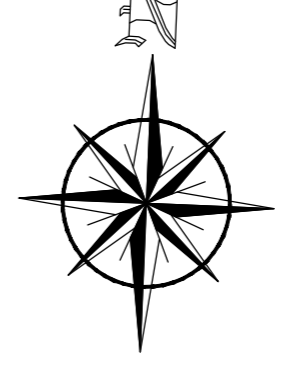

PLANNING DRAWING.
NOT FOR CONSTRUCTION.
ALL LEVELS GIVEN ARE
RELATIVE TO ORDNANCE DATUM.
THIS DRAWING HAS BEEN ISSUED FOR INFORMATION
PURPOSES ONLY AND MUST NOT BE USED
FOR CONSTRUCTION UNDER ANY CIRCUMSTANCES

NOTES

- For setting out refer to Architect's drawings.
- This drawing to be read in conjunction with all other Architectural and Engineering drawings and all other relevant drawings and Specifications.
- DO NOT SCALE THIS DRAWING. Use figured dimensions only.
- No part of this document may be reproduced or transmitted in any form or stored in any retrieval system of any nature without the written permission as copyright holder except as agreed for use on the project for which the document was originally issued.
- Ordnance Survey Ireland Licence Number EN 0074024

Rev. No.	Date	REVISION NOTE	Drn. By	Chkd. By
P1	17.07.2023	ISSUED FOR STAGE 2	SC	NB
P2	20.12.2023	ISSUED FOR IRISH WATER DESIGN ACCEPTANCE	SC	NB
P3	20.02.2024	ISSUED FOR IRISH WATER DESIGN ACCEPTANCE FOLLOWING COMMENTS	SC	AC
P4	27.02.2024	REVISED IN RESPONSE TO COMMENTS FROM USICE EIREANN	DO	AC
P5	28.02.2024	ISSUED FOR PLANNING	SC	LJ

Architect	Michael Fitzpatrick (MFA)
Project	Drummark Development Co. Cavan
Title	Proposed Drainage Layout
Dwg. No.	D111-CSC-XX-DR-C-0002
Date	June 2023
Drn. By	SC
Chkd. By	JF
Apprv. By	NB
Scale	1:500 @ A1
Revision	P5

CS Consulting Group
DUBLIN | LONDON | LIMERICK

Head Office
19-22 Dame Street, Dublin 2.
T: +353 (0)1 5480863
e: info@csconsulting.ie
www.csconsulting.ie

Quality
Environment
Energy
Health & Safety

ISO 9001:2008
ISO 14001:2004
ISO 50001:2011
OHSAS 18001:2007